

Serampore College

09, William Carey Road, Serampore, Hooghly, West Bengal, 712201

Faculty of Arts-Science-Commerce

NOTICE INVITING TENDER

Tender No.: SC-ASC/2022-23/89

Date: 31st January, 2023

Sealed quotations are invited mentioning for the following job(s)/materials for **Electrical Work in Principal's Office**. The quotations are to be dropped into the assigned box in Bursar's Office on or before **04th February, 2023, 12:00 noon** the quotations are to be opened at 1:00 P.M. in the Principal's Office on the 04th February, 2023 (depends on the availability of the competent authorities). Interested legitimate parties are welcome to attend. All quotations should include taxes as applicable. Submission of photocopies of License, PAN Card and GST Certificate (if not a registered vendor) of taxable entity is mandatory on the time of submission of quotations and bills. GST registered vendors will get preference in the selection process. This notice is also published on our website i.e., <https://seramporecollege.ac.in>. **N.B.:** Concerned authority reserves the right to judge the merit of the quotations and decide accordingly for issuing the work order or rejecting the same.

 
Description of Work(s)/Product(s): -

The work should be done as per the diagrams (page no. 3, 4 & 5).

- Separate main line from ground floor meter room to distribution box, which will supply Principal's Office and Board Room, replacing existing provisions.
- Only those with licence in relevant field or have authorisation from licenced Person (Electrical Work) are eligible to participate in the tendering process.


N.B.:

1. Vendors can survey the work (if required) before submission of quotations. They may contact Mr. Shouwick Sarkar (Mobile No.: - 9163638654), Campus Supervisor, Serampore College in this regard.
2. It is mandatory to mention the **business's name** on the envelope along with the **tender number** at the time of submission of quotations.


Mr. Jishnu Dasgupta

Bursar (ASC)

Bursar (ASC)
Serampore College
Serampore, Hooghly
West Bengal - 712201


Dr. Vansanglura

Principal & CEO

Principal & CEO
Serampore College
Serampore, Hooghly
West Bengal - 712201



 
Serampore College

09, William Carey Road, Serampore, Hooghly, West Bengal, 712201


Faculty of Arts-Science-Commerce


* TERMS & CONDITIONS:

1. The rate should be quoted both in figure and words. The rate should be inclusive of all taxes and incidental charges. Only one quotation paper will be accepted from each contractor.
2. Before dropping, those intending to submit quotations are requested to inspect the site. No extra charges will be entertained after accepting the quotation. No conditional quotation will be entertained.
3. The payment will be made after successful completion of work subject to availability of fund.
4. Acceptance of lowest quotation is not obligatory and the undersigned reserves the right to accept/reject any or all the quotation/s received at his discretion without assigning any reason whatsoever at any stage.
5. The successful contractor must complete the work within 30 days unless otherwise mentioned. No extension of time will be allowed except in special case. If any contractor fails to complete the work within the stipulated time, the work order issued in his favour will be cancelled without assigning any reason thereof. The undersigned may also proceed to get the balance work completed by any other means including through other contractors. The excess expenditure, if any, due to such a step would be recoverable from the unpaid bills, security deposit of the contractors/vendors. This is apart from any other protective measure. The undersigned may take including black listing of the contractors and forfeiture of earnest money.
6. All works will have to be done according to the specification, design and details approved by the Building Committee concerned and as per directions of the Principal, Serampore College.
7. The successful contractor/vendor will have to abide by the provisions of the West Bengal Contract Labour (Regulation & Abolition), Rules, 1972 as will be in force from time to time.
8. The contractor/vendor who does not fulfil any or all of the above noted conditions and submit incomplete quotation, the same will be summarily rejected. The quotation notice will form a part of agreement.
9. All terms and conditions will be followed by PWD rules and norms. Any other information of such relevant matter not included in the notice may be gathered from the office of the undersign in any working days during office hours prior to date of opening of this quotation.
10. Those who have GST Registration will have to submit GST inclusive Quotations and GST Bills (Regular GST or Composite GST as applicable). The taxes and government duties as applicable will be deducted from the bill of the contractor.
11. Quotations will be accepted sent by Post only duly received by the College Administration.
12. Materials: All materials required for the works, if supplied by the contractor should be of the best quality & ISI Marked then approved by college authority.
13. Labour, tools, plants etc.: The contractor shall supply all tools, plants and labour required for carrying out the Work.
14. No damage should be caused to any other college property while the work is done. If any damage is caused, then you will be liable to restore it to its original shape.


Mr. Jishnu Dasgupta
Bursar (ASC)
Bursar (ASC)
Serampore College
Serampore, Hooghly
West Bengal - 712201





Dr. Vansanglura
Principal & CEO
Principal & CEO
Serampore College
Serampore, Hooghly
West Bengal - 712201

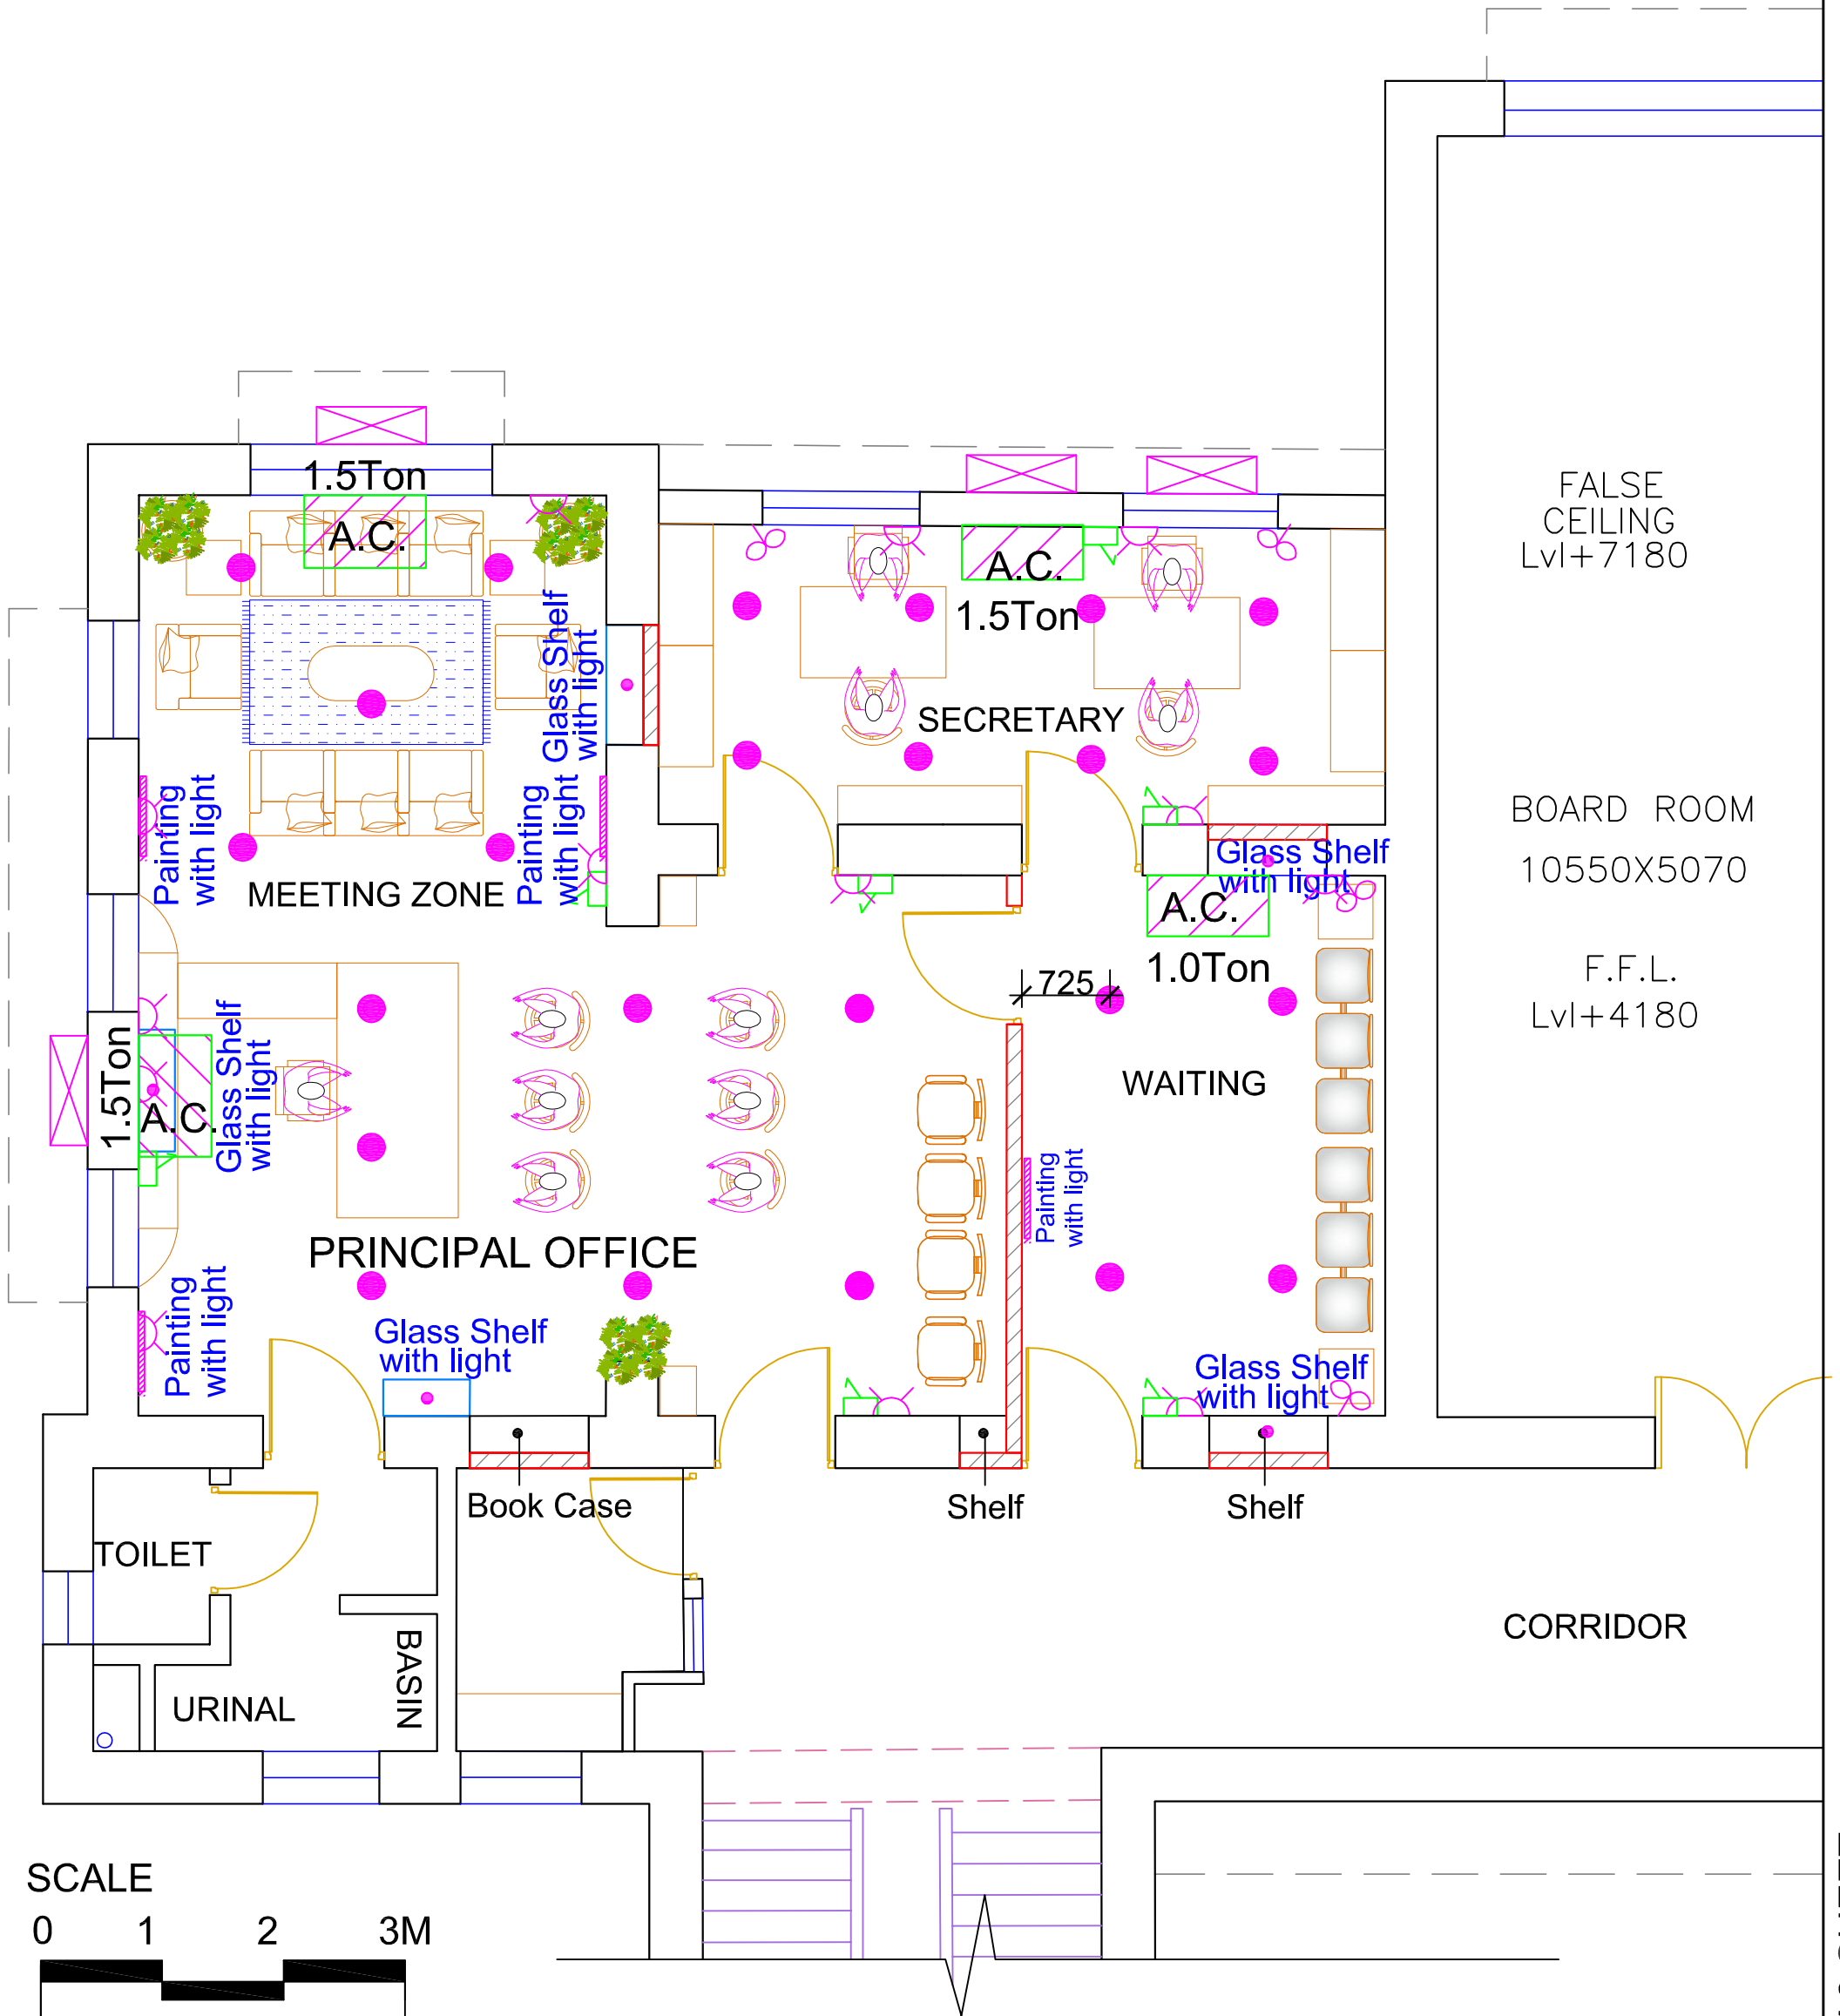

ELECTRICAL LAYOUT FOR PRINCIPAL OFFICE AT GEORGE HOWELL BUILDING AT SERAMPORE COLLEGE



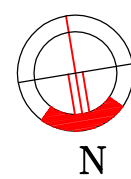




 
 

DRAWN TRIPTI
 DATE 18.12.2022
 SCALE AS_SHOWN
 APPROVED G.SEN



The Designers
 ARCHITECTS • CONSERVATION ARCHITECTS
 ENGINEERS • INTERIOR DESIGNERS
 539A BLOCK-N • NEW ALIPORE • KOLKATA-53

DWG. NO. SER/2022/Colg_Admin/ELEC-01 REV.-02

LEGEND FOR ELECTRICAL:-

SL. NO.	SYMBOL	DESCRIPTION	NOS
01		SWITCH BOARD WITH 6A SKT.	8
02		6/16A SOCKET	12
03		WALL BRACKET FAN	4
04		10W ROUND RECESSED MOUNTED LED DOWNLIGHTER	24
05		7W LED PICTURE LIGHT	4
06		3W LED SPOT LIGHT	5
07		16W T5 LED WALL MOUNTED TUBE LIGHT	1
08		AIR CONDITION WITH SWITCH, 16 AMP SOCKET EXISTING 3 ACs WILL BE REUSED.	3+ 1(NEW)
09		SPACE FOR AC OUTDOOR UNIT	4
10		MAIN DISTRIBUTION BOARD	

SPECIFICATIONS


1. PVC PIPE 20/25MM - POLYCAB, FINOLEX
2. PVC INSULATED FR WIRE- POLYCAB, FINOLEX
3. SWITCH, SOCKET- ROMA, MDS MARIO'S
4. DISTRIBUTION BOX- MDS, HAVELLS
5. LED LIGHT- PHILIPS, HAVELLS, SYSKA, CROMPTON
6. SPOT LIGHT- SAME AS SL.5
7. WALL FAN- CROMPTON, BAJAJ
8. A.C- VOLTAS, LG, IFB

NOTES

1. BEFORE A.C. INSTALLATION EXISTING LOAD CAPACITY SHOULD BE CHECKED FOR CONFORMITY
2. BRACKET FAN HAS NOT BEEN SHOWN IN PRINCIPALS' ROOM. IF REQUIRED POSITION OF BRACKET FANS SHALL BE SHOWN LATER.
3. ALL COMPUTERS SHALL HAVE 1 16AMP SOCKET AND 3 6AMP SOCKETS
4. 6/16 AMP SOCKET AT THE LEFT SIDE OF PRINCIPAL'S TABLE FOR CCTV MONITOR.
5. ALL SWITCH BOARDS AT 1500MM FROM FINISHED FLOOR LEVEL.
6. ALL 6/16 AMP SOCKETS AT ABOVE SKIRTING LEVEL.
7. STRUCTURAL HEIGHT FROM FLOOR TO BOTTOM OF SLAB IS 3470MM AND FALSE CEILING HEIGHT IS 2800MM
8. MAXIMUM 3 CEILING MOUNTED LIGHTS PER SWITCH.
9. CEILING MOUNTED LIGHTS AT PRINCIPAL'S ROOM WILL BE OPERATED FROM TWO SWITCH BOARDS(TWO WAY)
10. APP. LENGTH OF PIPE OF WIRES
 - a. PIPE OF 25/20MM -105 PCS.
 - b. A.C(1.5 TON) RED 35MTR.,BLACK35MTR., GREEN35MTR.
 - c. A.C(1TON) RED7MTR.,BLACK7MTR.,GREEN7MTR.
 - d. CIRCUIT(DB TO SB) RED140MTR.,BLACK140MTR.,GREEN140MTR.
 - e. POINT(SB TO POINT) RED225MTR., BLACK225MTR., GREEN180MTR.

**ELECTRICAL LAYOUT FOR PRINCIPAL
OFFICE AT GEORGE HOWELL BUILDING
AT SERAMPORE COLLEGE**


DRAWN TRIPTI
DATE 18.12.2022
SCALE AS_SHOWN
APPROVED G.SEN

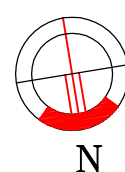



The Designers
ARCHITECTS • CONSERVATION ARCHITECTS
ENGINEERS • INTERIOR DESIGNERS
539A BLOCK-N • NEW ALIPORE • KOLKATA-53

DWG. NO. SER/2022/Colg_Admin/ELEC-02 REV.-03

3

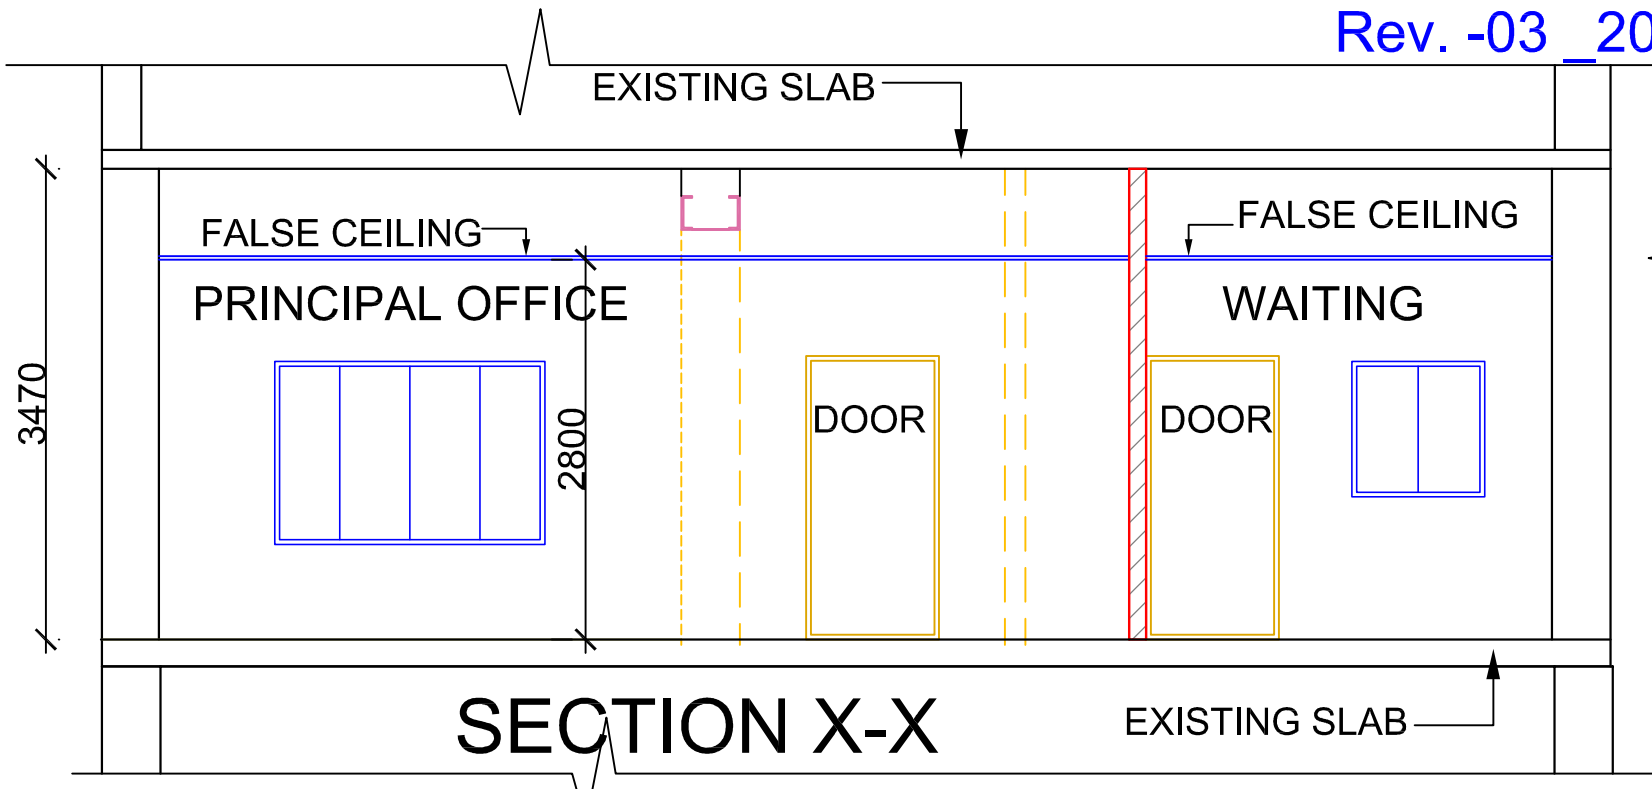


SECTION X-X

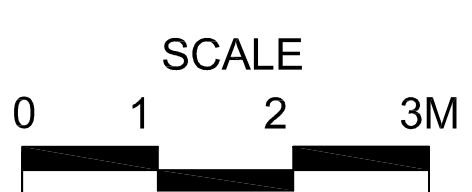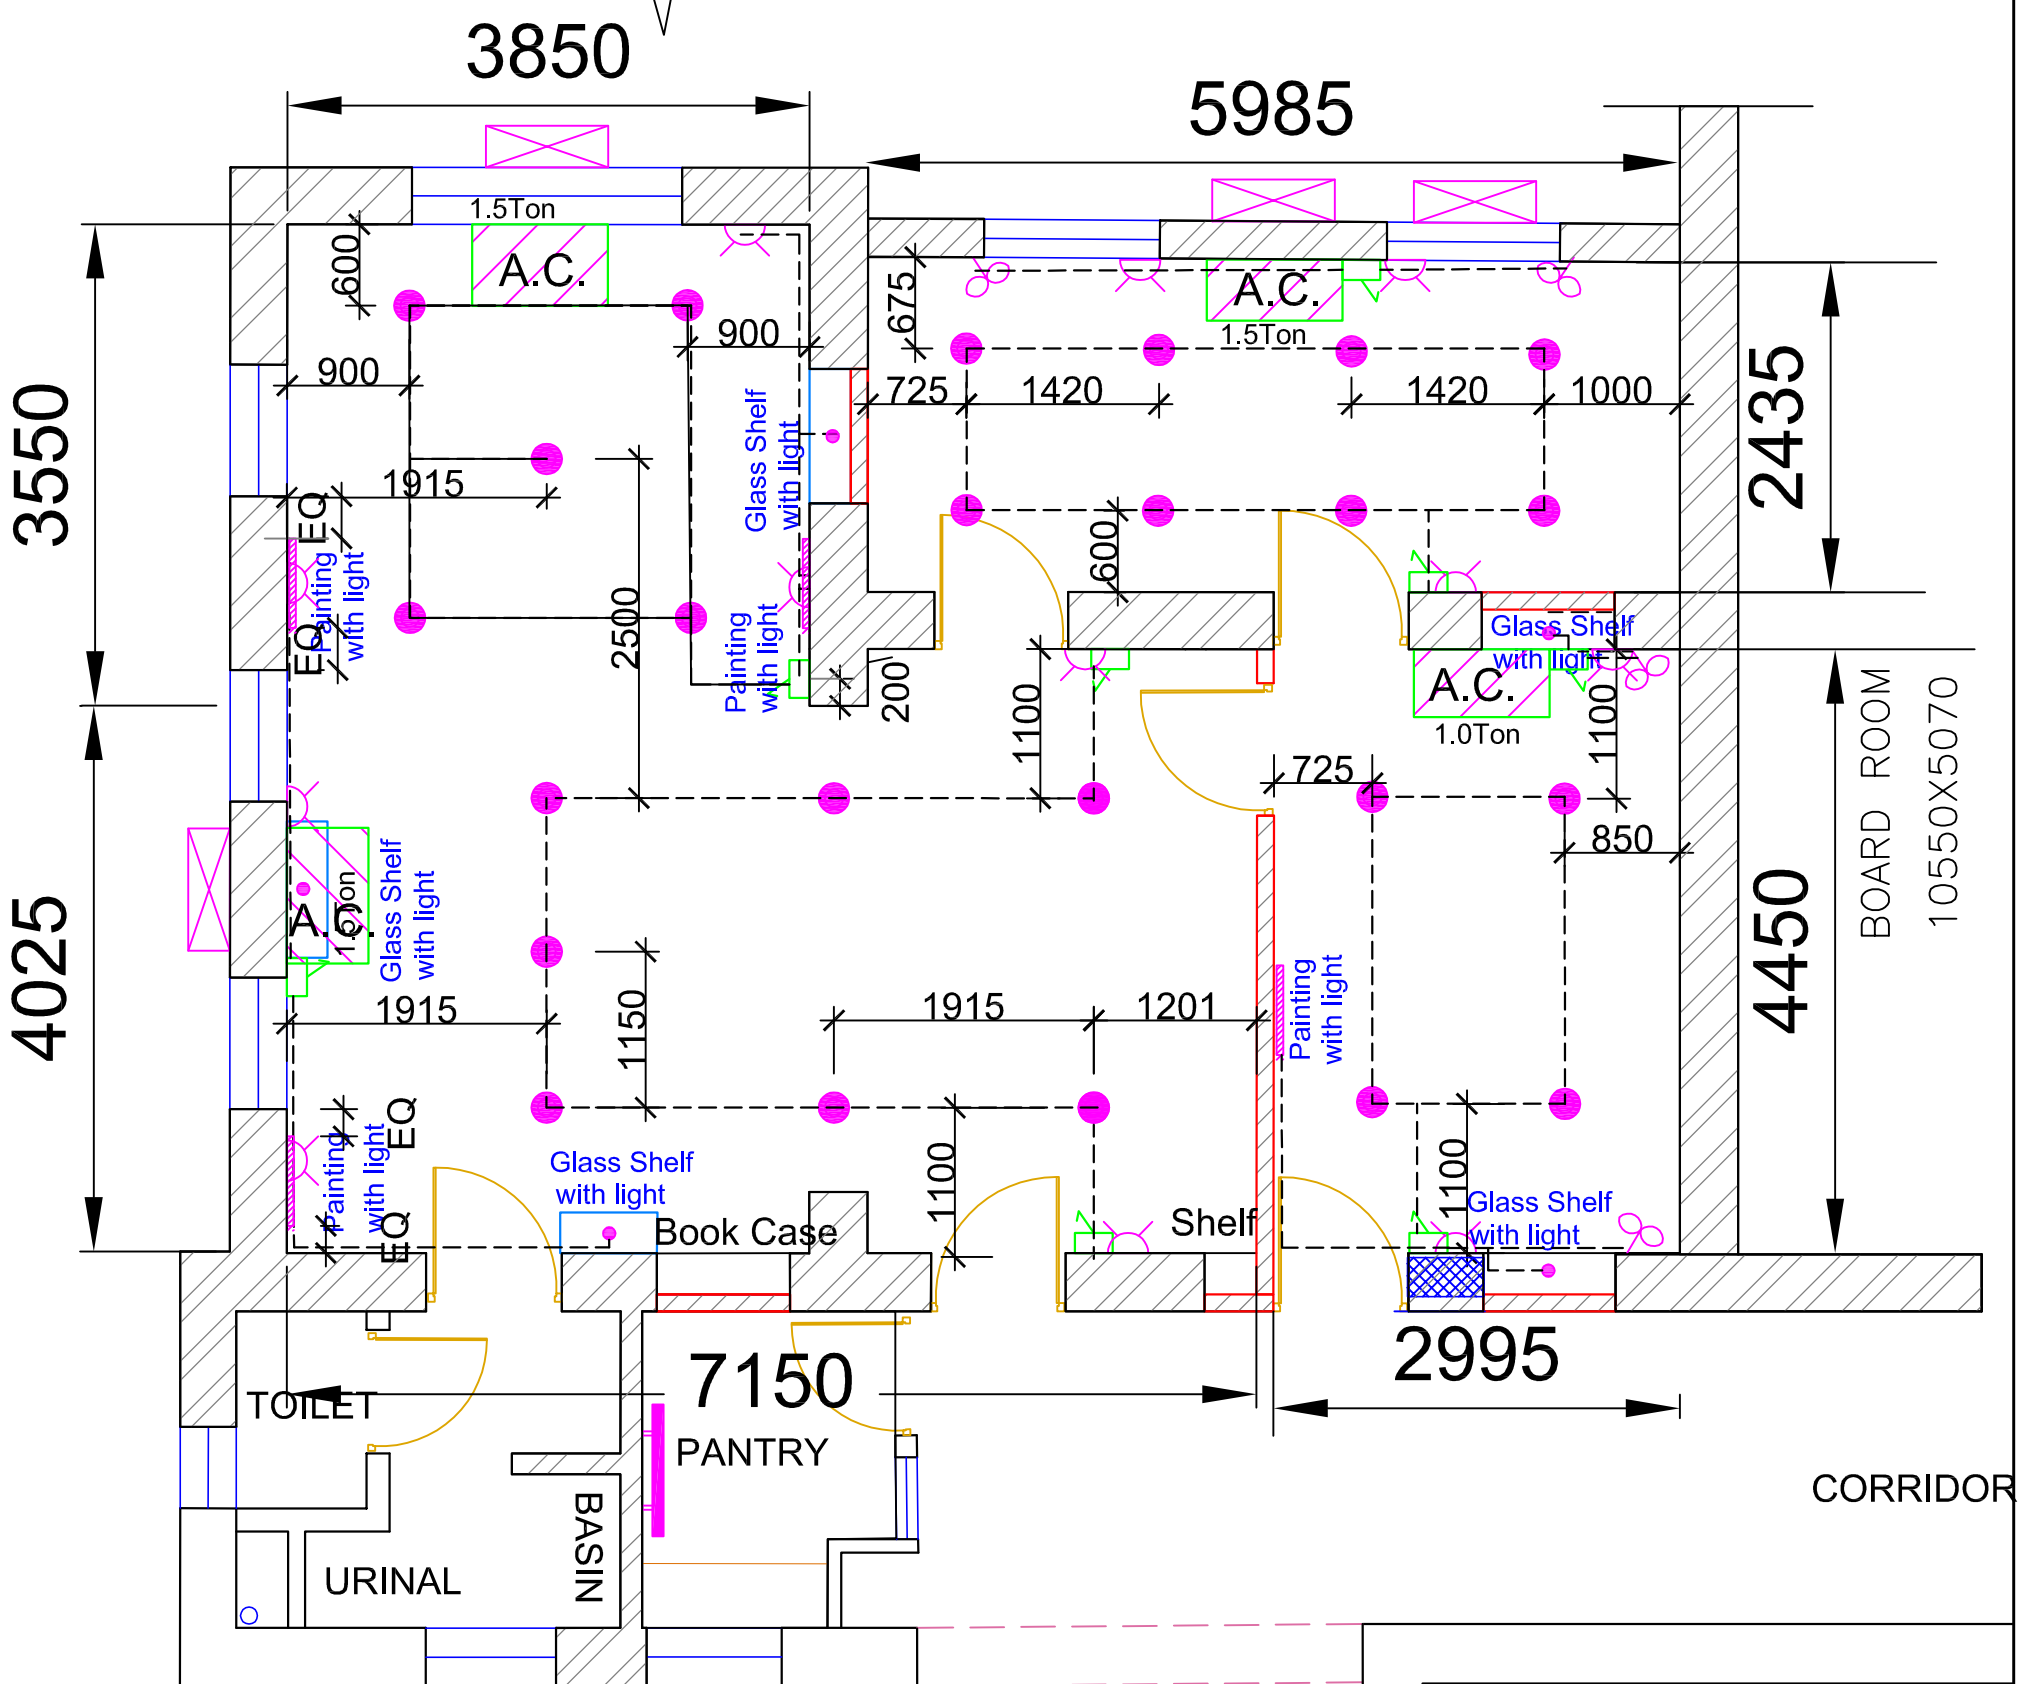

ELECTRICAL LAYOUT FOR PRINCIPAL OFFICE AT GEORGE HOWELL BUILDING AT SERAMPORE COLLEGE

DRAWN	TRIPTI
DATE	18.12.2022
SCALE	AS_SHOWN
APPROVED	G.SEN

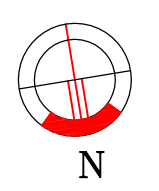

The Designers
 ARCHITECTS • CONSERVATION ARCHITECTS
 ENGINEERS • INTERIOR DESIGNERS
 539A BLOCK-N • NEW ALIPORE • KOLKATA-53

DWG. NO. SER/2022/Colg_Admin/ELEC-02 REV.-03

PRINT IN A3 SHEET